

SITE / CIVIL ENGINEER
KEYSTONE CONSULTING ENGINEERS, P.C.
6235 HAMILTON BLVD., WESCOVILLE, PA 18106
(610) 375-6971

LANDSCAPE ARCHITECT
N/A

STRUCTURAL ENGINEER
UUTS ENGINEERING
1855 HOWA-SI. YOC. PA 17408
VT78.52.1268

MECHANICAL ELECTRICAL PLUMBING
LEBOH W. DESIGN (00110)
1 W. BROOKSIDE RD. WILKES-PA 18118
(610) 866-3870

FIRE PROTECTION ENGINEER
LEBOH W. DESIGN (00110)
1 W. BROOKSIDE RD. WILKES-PA 18118
(610) 866-3870

TELECOM ENGINEER
N/A

AUDIO VISUAL ENGINEER
N/A

SECURITY ENGINEER
N/A

ACOUSTICAL ENGINEER
N/A

DRAWING HISTORY
j NO.1 (S/A) DATE: 1 DISOPT(CX)

CURRENT ISSUE

08/30/2017

**©RIGHT 2016 SFA
REGISTRATION**


**LOWER MACUNGIE
TOWNSHIP**
3400 Brookside Rd
Macungie, PA 18062

**LOWER MACUNGIE TWP.
COMMUNITY CENTER
ALTERATIONS**

OVERALL FLOOR PLAN

PROJECT NUMBER 7716.16

A0.01

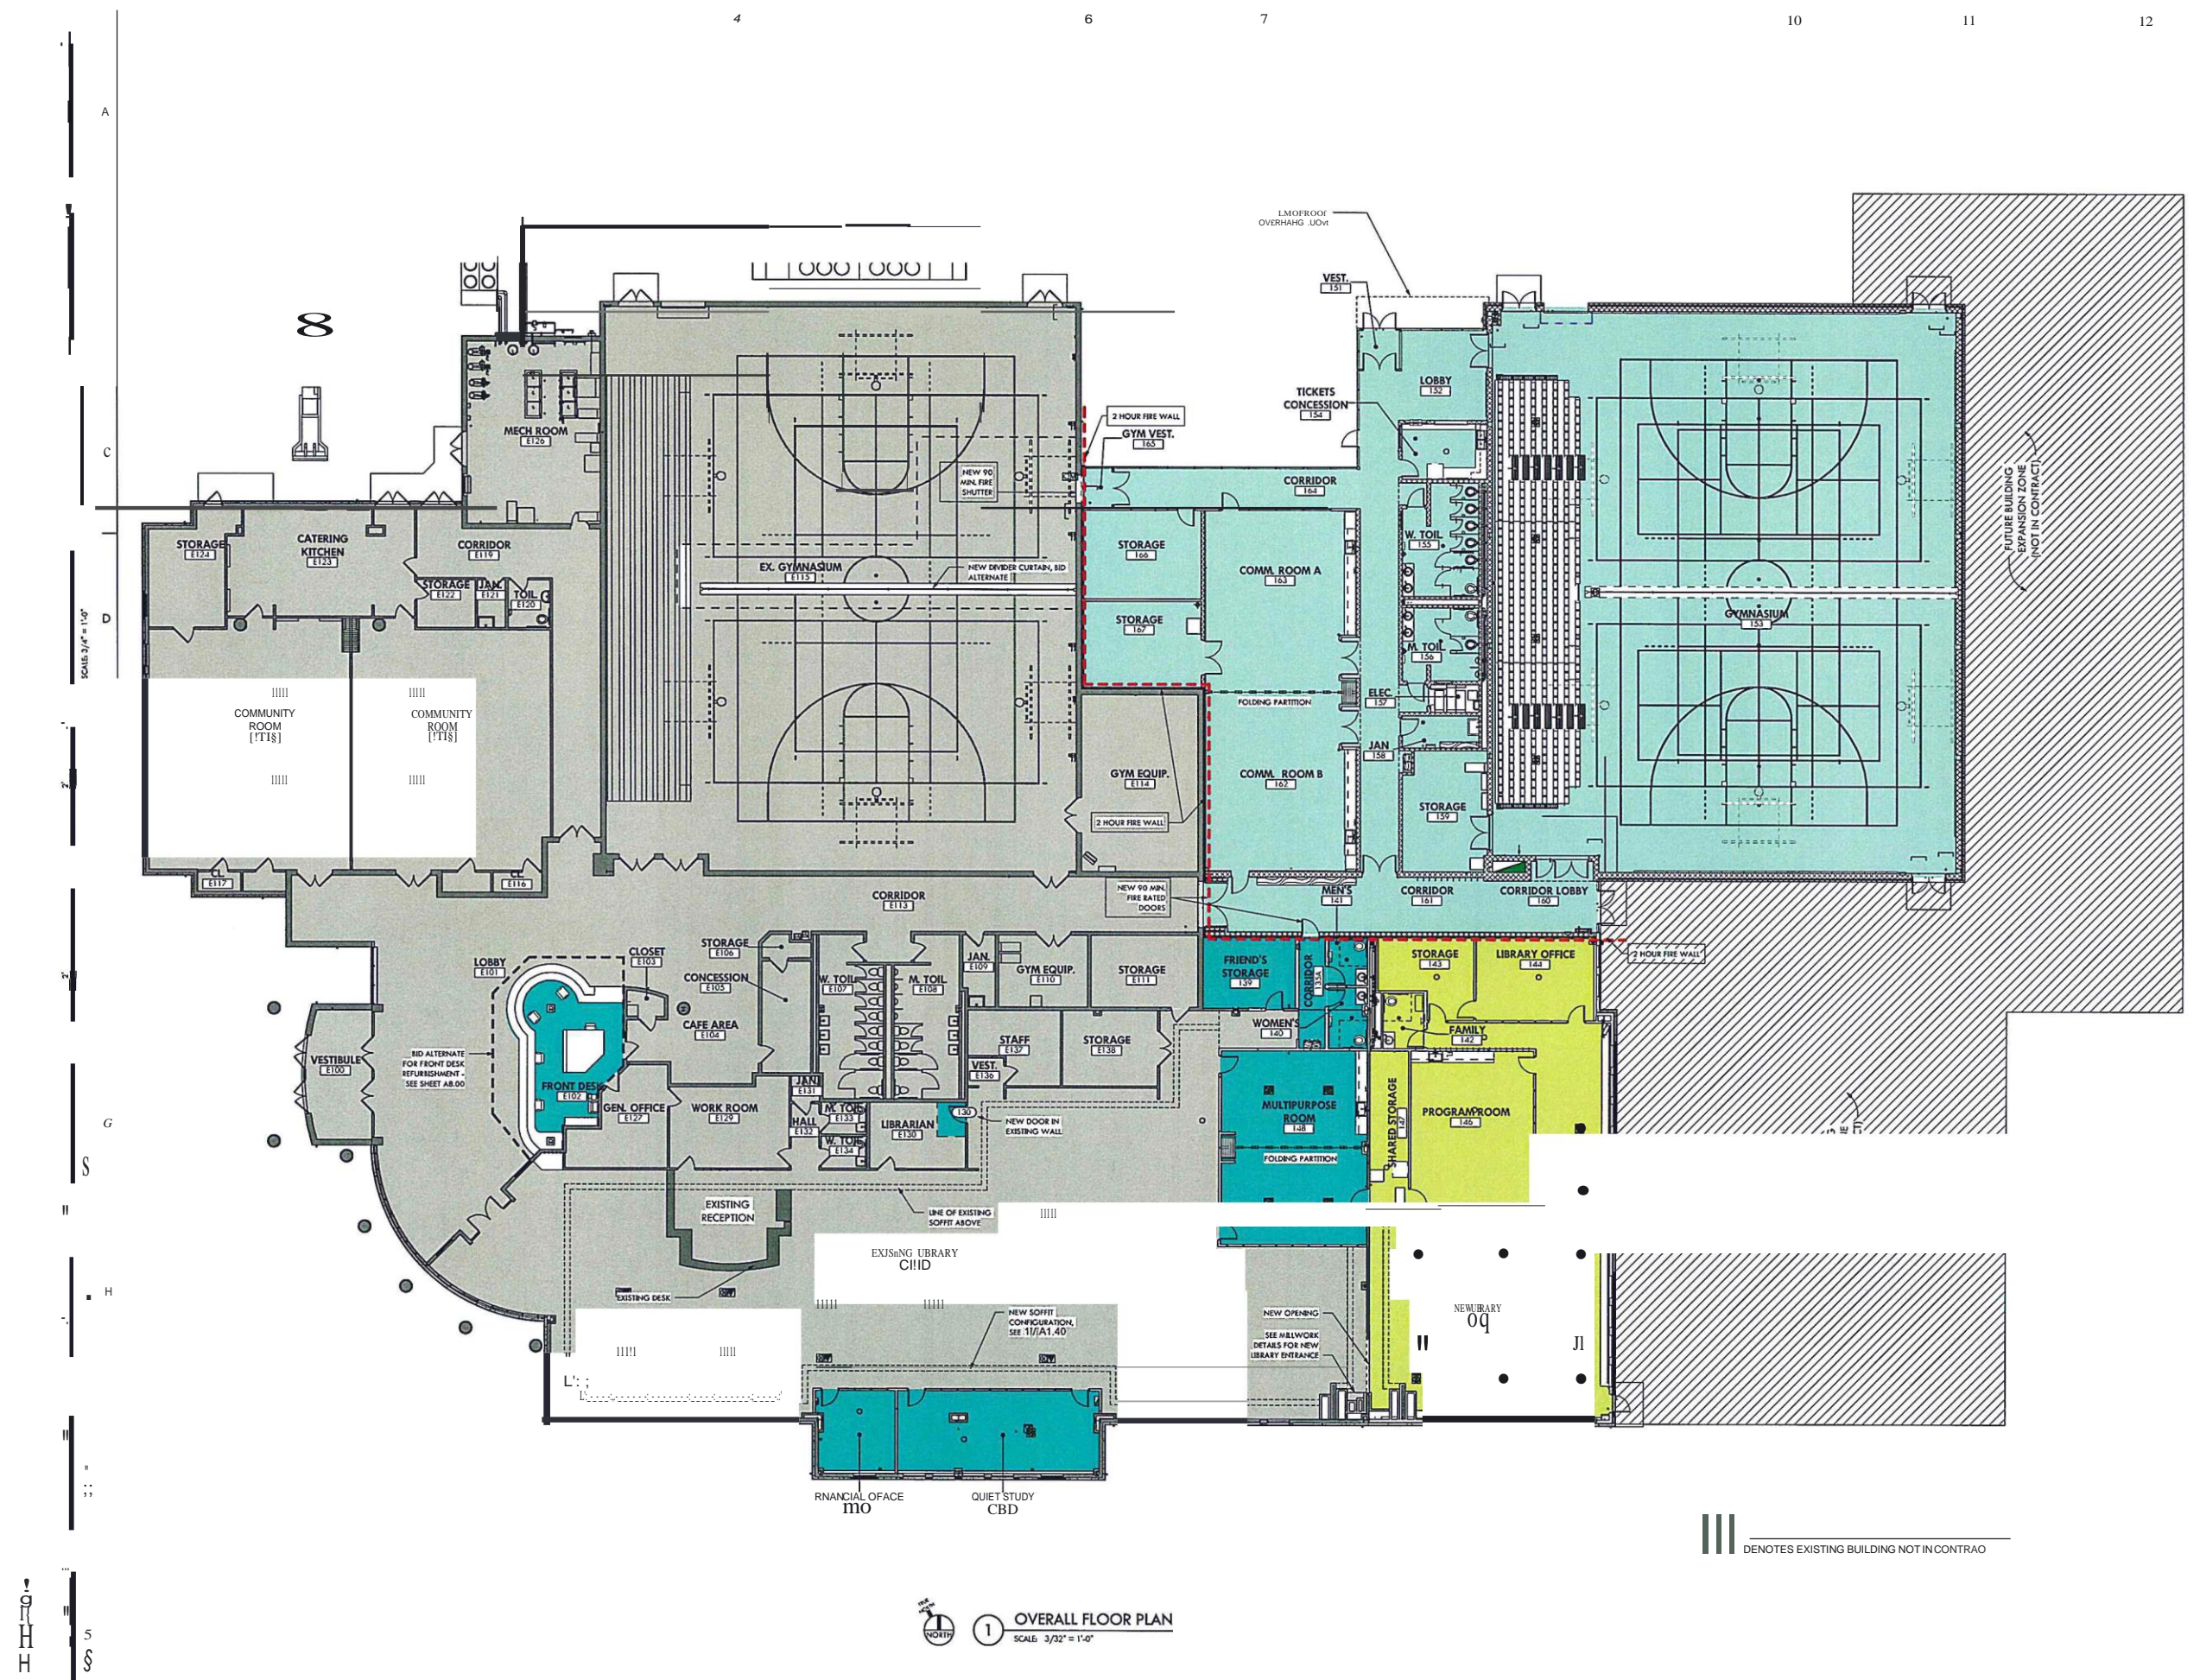

1 OVERALL FLOOR PLAN
SCALE: 3/32" = 1'-0"

||||| DENOTES EXISTING BUILDING NOT IN CONTRACT

5
6